
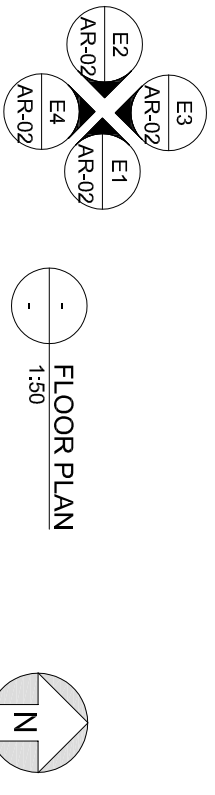
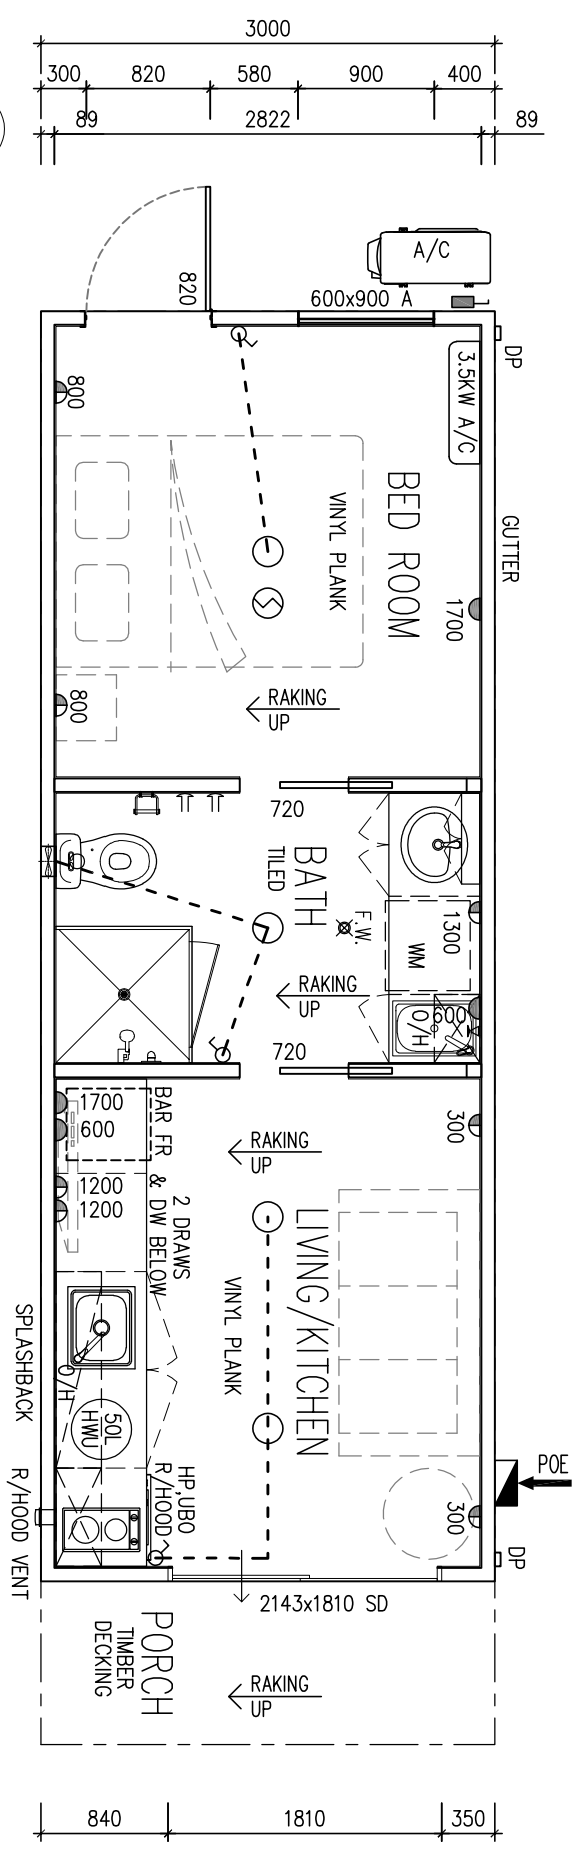


| ELECTRICAL LEGEND | |
|-------------------|---------------------------------------|
| | = ELECTRICAL POINT OF ENTRY |
| | = ELECTRICAL DISTRIBUTION SWITCHBOARD |
| | = 10A TWIN SWITCHED GPO |
| | = 10A SINGLE SWITCHED GPO |
| | = LED DOWNLIGHT |
| | = ONE GANG SWITCH |
| | = WALL MOUNTED EXHAUST FAN |
| | = SMOKE DETECTOR |
| | = EXTERNAL ISOLATOR, WEATHERPROOF |
| | = RANGE HOOD |

NOTE: POWER TO DISHWASHER, HOT PLATE, OVEN & RANGE HOOD

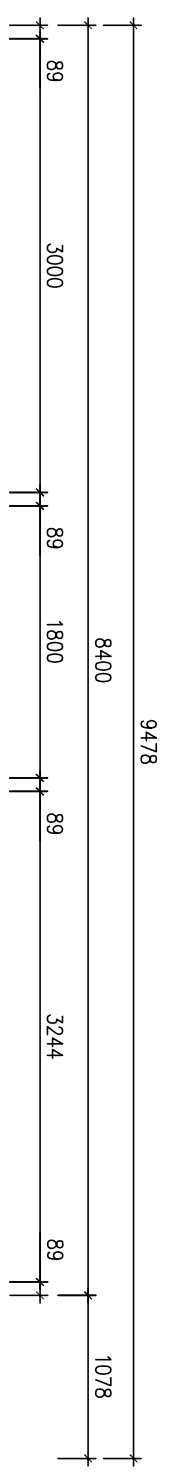

| REVISIONS | | | | | |
|-----------|------------|-----|-----|----------------------|--|
| REV | DATE | DRN | CHK | DESCRIPTION | |
| TA | 29.07.2024 | ST | NC | ISSUED FOR REVIEW | |
| TB | 07.10.2024 | ST | BH | RE-ISSUED FOR REVIEW | |
| | | | | | |
| | | | | | |
| | | | | | |

| REVISIONS | | | | | |
|-----------|------|-----|-----|-------------|--|
| REV | DATE | DRN | CHK | DESCRIPTION | |
| | | | | | |
| | | | | | |
| | | | | | |
| | | | | | |

SN: -

| | |
|-----------------|------------------------------|
| CLIENT: | MATT HANKIN |
| PROJECT: | 89 HUBBLE ST, EAST FREMANTLE |
| SHEET TITLE: | HOUSE 8.4m X 3.0m FLOOR PLAN |
| SCALE: | AS SHOWN (A3) |
| DRAWING NUMBER: | AR-01 |
| REV | TB |

